


**Electrical Legend**

- x Amp | Electrical Drop Location
- | Internet Drop Location

**Electrical Requirements**

- (6) 10 amp
- (1) Internet Drop Point

Extension Cord Location

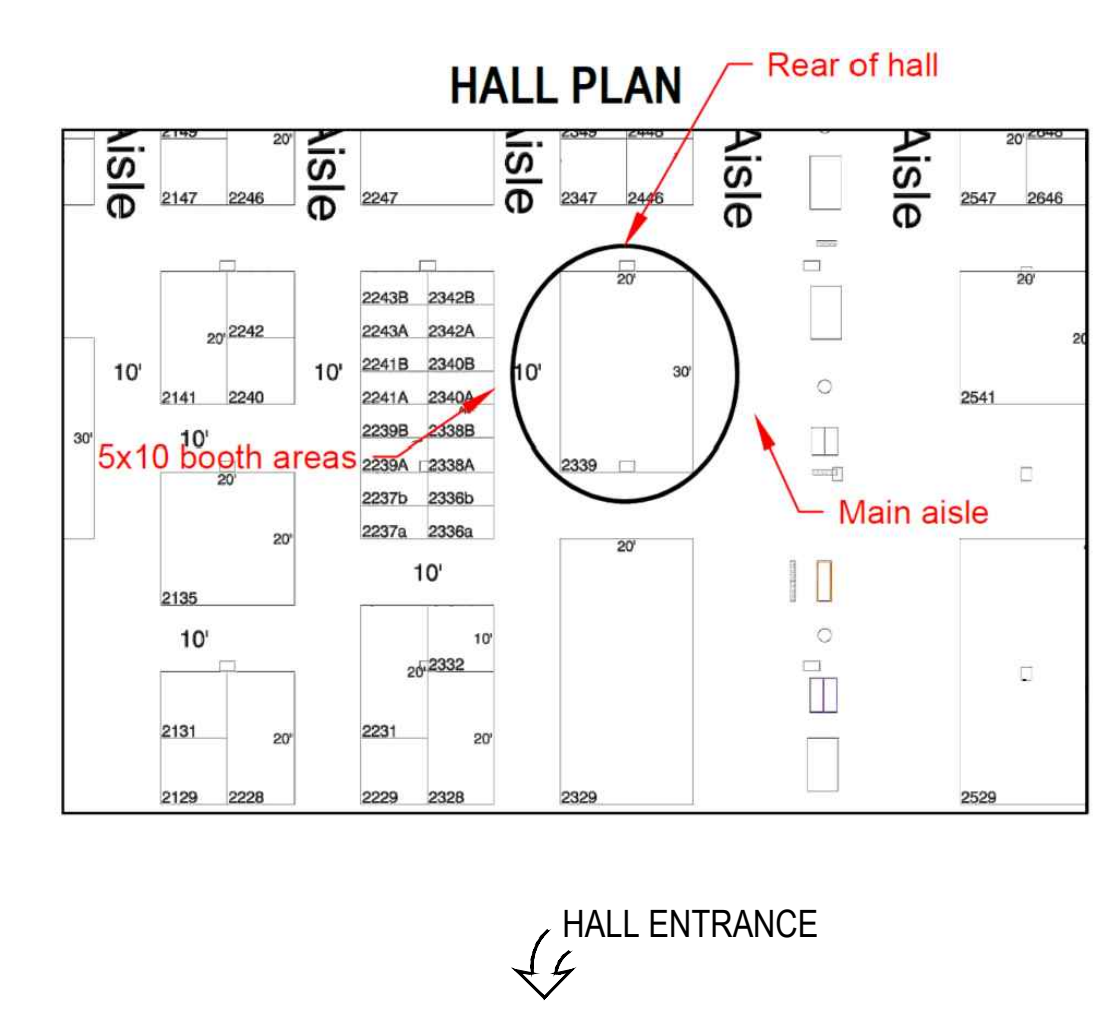

1 TOP WITHOUT HANGING PANELS  
Scale: 1/2" = 1'-0"

**Booth #2339**  
**Electrical Plan**

Drawn by: Elise Masur  
File ID: D01  
Page: 10 OF 10  
Revision #: 15  
Plotted: 09/27/17

Full Scale: 36"x24" | 50%: 11x17 | Not to Scale: 8.5x11